



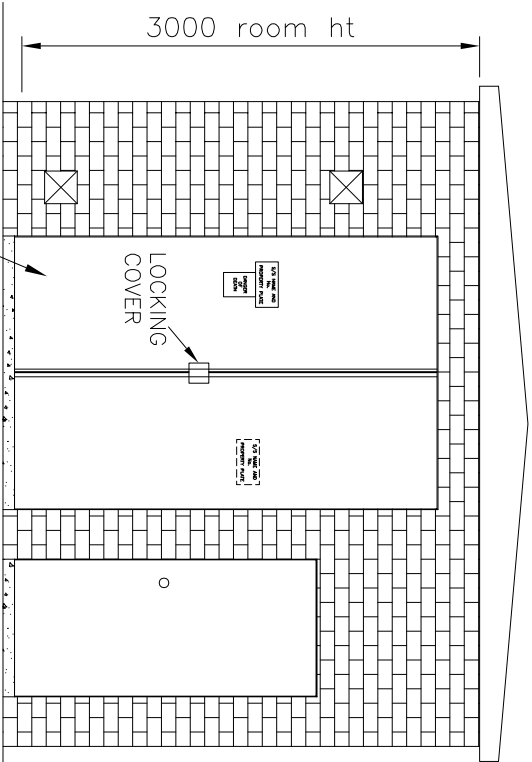


FRONT ELEVATION


SUBSTATION DOORS TO MEET
NORTHERN POWERGRID SPECIFICATION
WITH 1810x2850 HIGH BRICKWORK
OPENING. LEFT LEAF TO OPEN FIRST

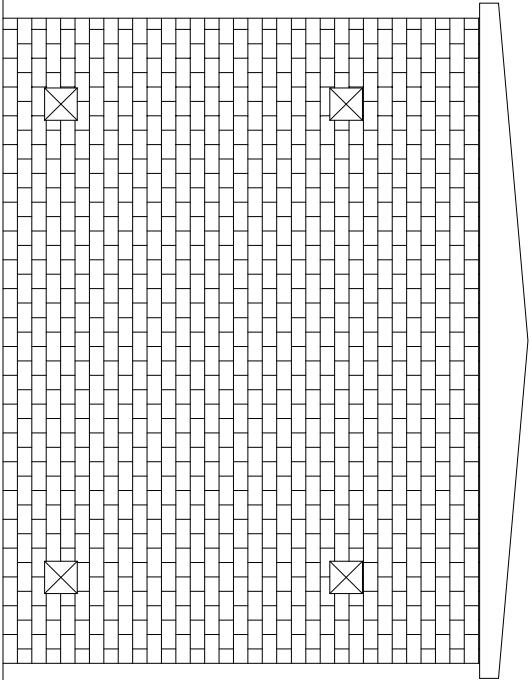

REAR ELEVATION

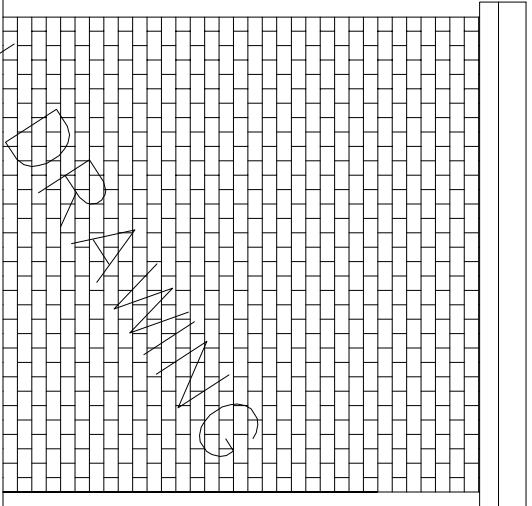


SIDE ELEVATION

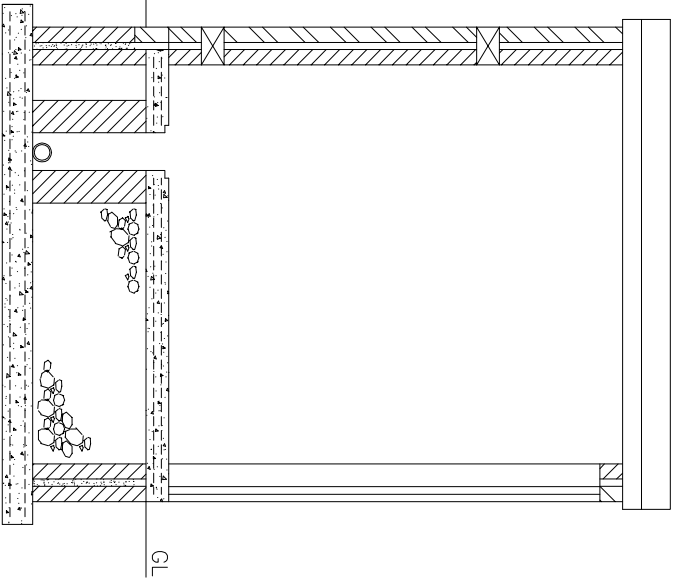


SECTION A—A

NOTES

Substation doors to be set back a minimum of 1500mm from back edge of footpath. Any proposed reduction in this clearance to be approved by Northern Powergrid following submission of site specific risk assessment and operational method statement.

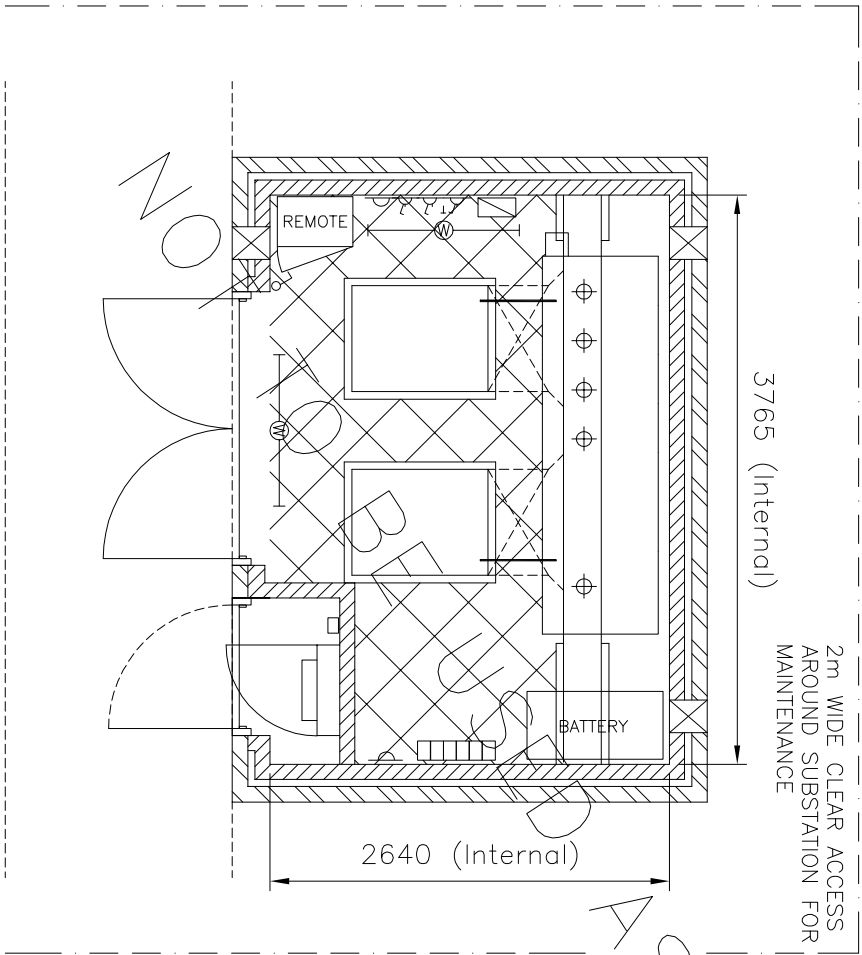

PLAN

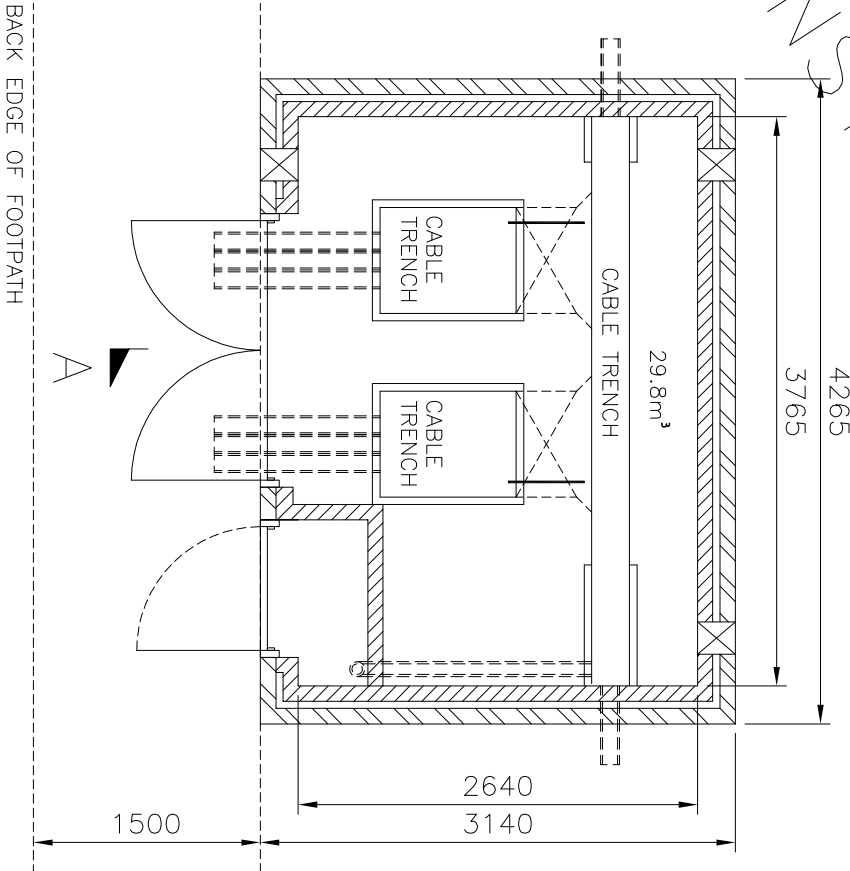

ELECTRICAL LAYOUT



Lloyds Court, 78 Grey Street, Newcastle Upon Tyne, NE1 6AF

20kV EXTENSIBLE HV PANEL WITH METERING ANNEXE
IN MASONRY ENCLOSURE

Manufacturer Details

Sheet No. 1 Scale AS SHOWN

Prepared By

Revised TM Grid Reference

Date Issued 17.05.16

Checked By JU

Revision B

Document Details

GENERAL ARRANGEMENT / PLAN & ELEVATIONS

Ref No. C993905

Notes